


REFLECTED CEILING PLAN SYMBOLS			
	EXPOSED CONSTRUCTION SEE ROOM FINISH SCHED, DETAILS AND STRUC DWGS		SURFACE MOUNTED INCANDESCENT LIGHT FIXTURE REFER TO ELEC DWGS
	2' x 2' LAY-IN ACOUSTIC CEILING TILE (ACT) OR VINYL FACED CEILING TILE (VACT)		RECESSED INCANDESCENT LIGHT FIXTURE REFER TO ELEC DWGS
	PLAS-GBD-STUCCO-EIFS (AS PER SCHEDULE) CJ - REFER TO DETAIL		SPEAKER S = SURFACE MOUNTED R = RECESSED
	GYPSON BOARD CEILING TILE		EMERGENCY LIGHT FIXTURE S = SURFACE MOUNTED R = RECESSED
	SUSPENDED GRID W/ WIRE MESH		SMOKE DETECTOR REFER TO MECH/ELEC DWGS
	GRILLES, DIFFUSERS OR REGISTERS REFER TO MECH DWGS		EXIT LIGHT REFER TO ELEC DWGS
	LINEAR DIFFUSER REFER TO MECH DWGS		SPRINKLER HEAD REFER TO MECH DWGS
	RECESSED FLUORESCENT LIGHT FIXTURE REFER TO ELEC DWGS		LIGHT TRACK REFER TO ELEC DWGS
	SURFACE MOUNTED FLUORESCENT LIGHT FIXTURE REFER TO ELEC DWGS		PARTITIONS THAT CONTINUE TO STRUCTURE ABOVE AND CLOSE OFF SPACE
	NIGHT LIGHT OR EMERGENCY FIXTURE REFER TO ELEC DWGS		SMOKE ALARM
			FIRE ALARM


CEILING PLAN NOTES :	
ACT1 - STANDARD TILE	ACT2 - RECESSED EDGE TILE
1. REFER TO ROOM FINISH SCHEDULE FOR OTHER CEILING INFORMATION (MATERIALS - FINISHES - HEIGHT)	
2. FIREPROOF ALL PENETRATIONS IF CEILING IS SCHEDULED TO BE FIRE RATED (REFER TO CODE PLANS)	
3. COORDINATE EQUIPMENT AND FIXTURE LOCATIONS WITH MECHANICAL AND ELECTRICAL DRAWINGS.	
4. VERIFY LOCATIONS OF CEILING ACCESS PANELS TO EQUIPMENT ABOVE WITH MECHANICAL AND ELECTRICAL DRAWINGS.	
5. SPEAKER INSTALLER TO CUT ACT TILE FOR SPEAKER INSTALLATION - COORD. WITH ELEC.	

REV NO	DESCRIPTION	DATE
1	Addendum #2	12/17/2021
2	Addendum #3	12/29/2021

1 REFLECTED CEILING PLAN PHASE 3
 1/8" = 1'-0"

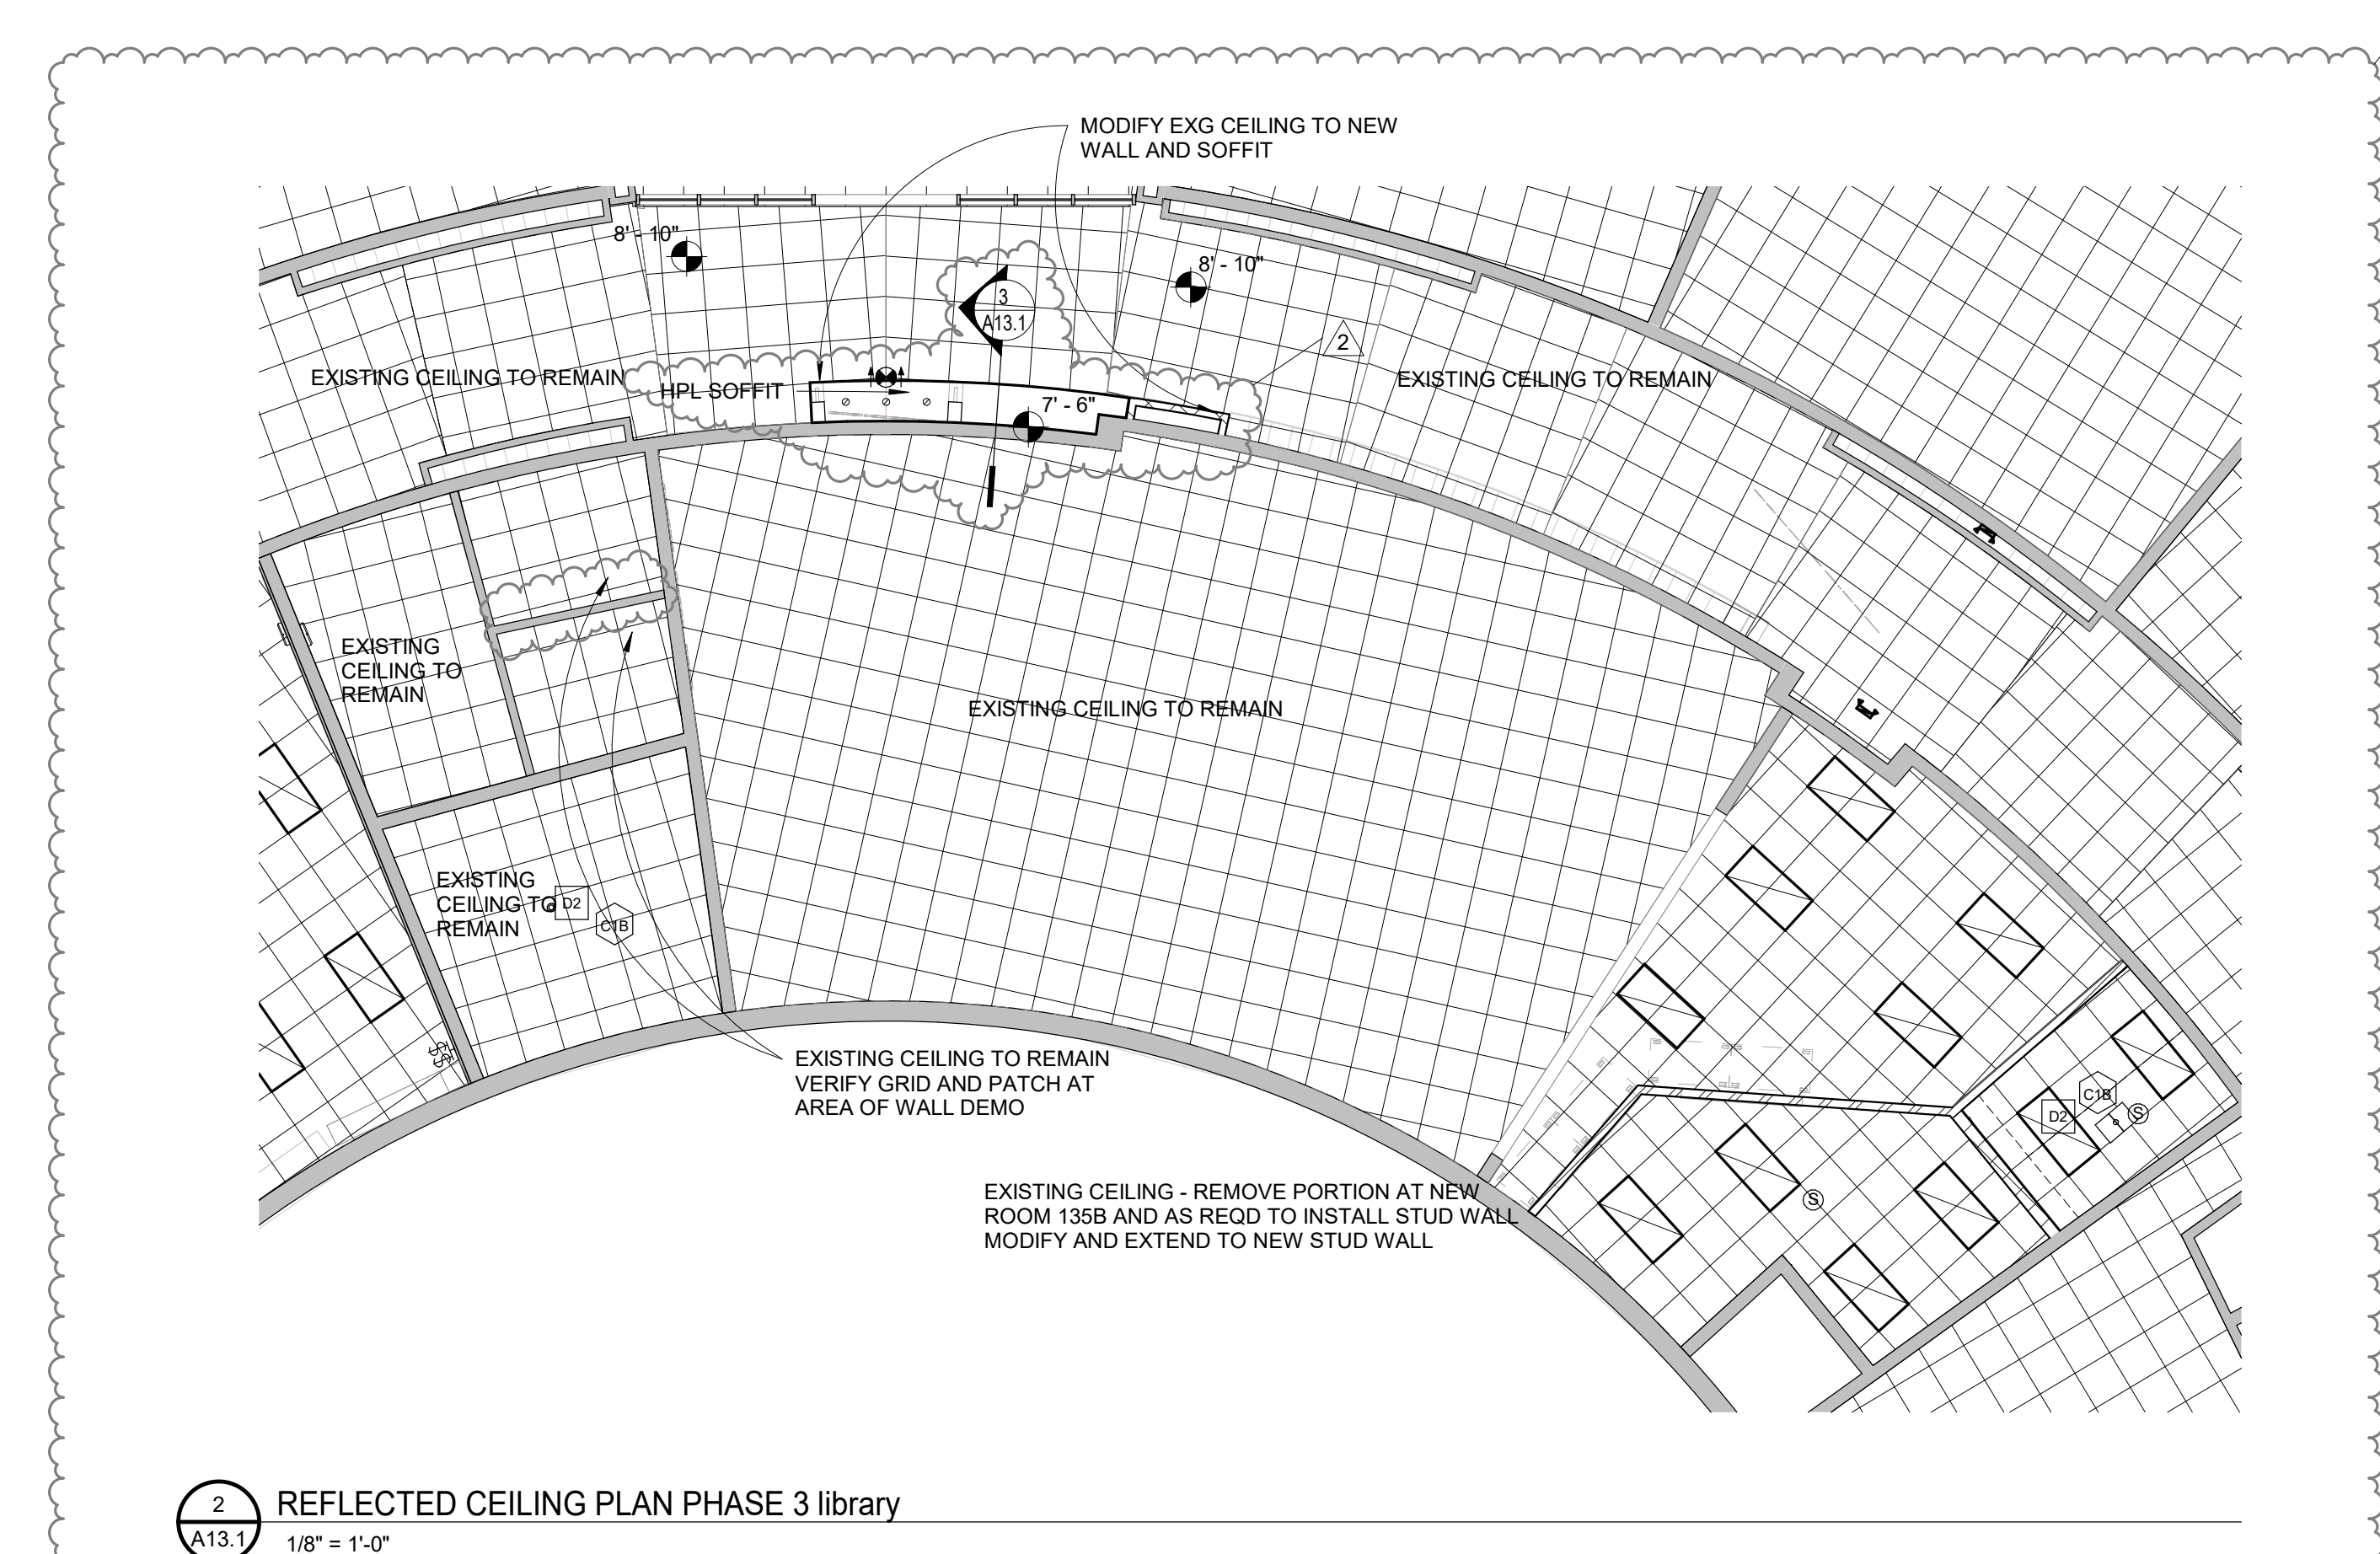


2 REFLECTED CEILING PLAN PHASE 3 library
 1/8" = 1'-0"

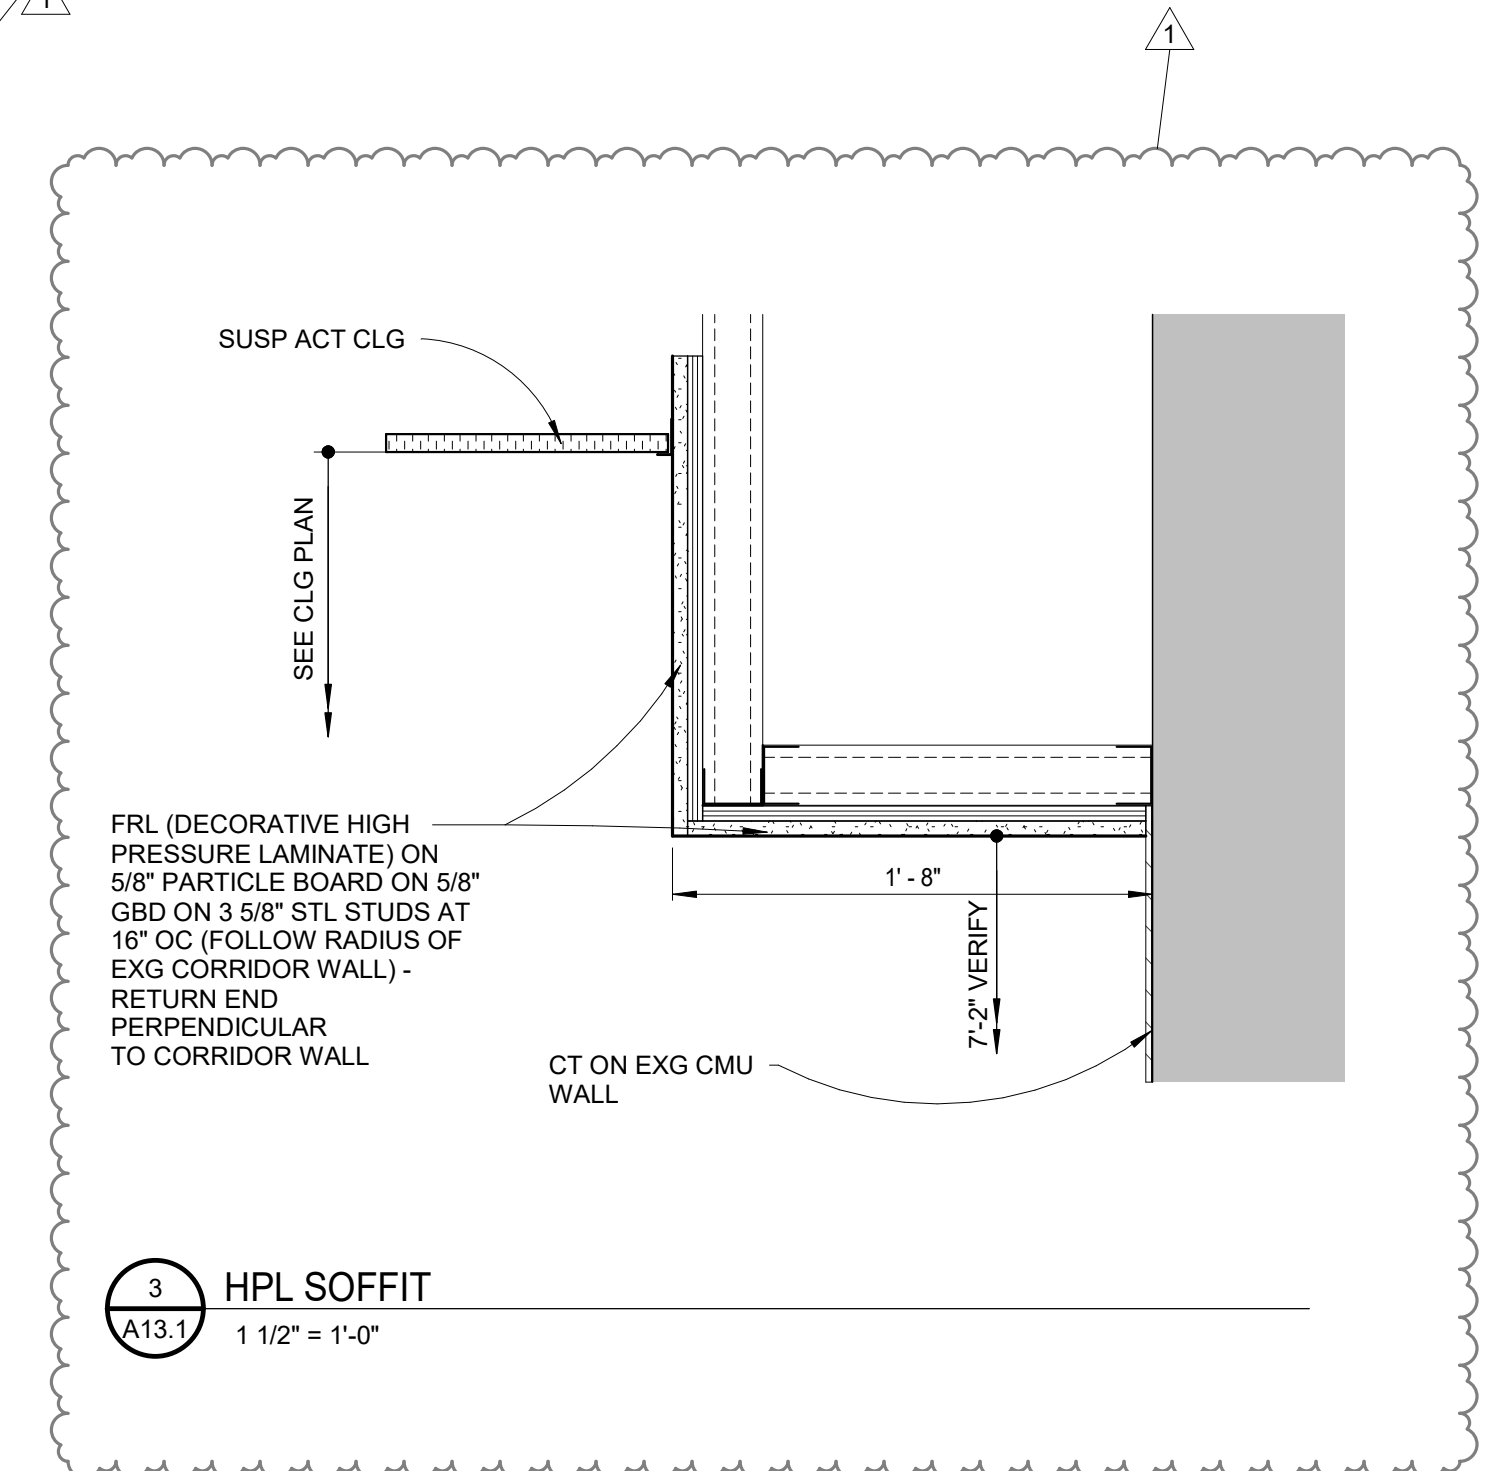

3 HPL SOFFIT
 1/12" = 1'-0"

SIGNATURE / SEAL
 I hereby certify that this plan, specification, or report was prepared by me or under my direct supervision and that I am a duly licensed Architect under the laws of the State of Minnesota.

Signature: *David M. Maroney*
 David M. Maroney, AIA
 Typist or printed name: October 27, 2021
 Date: 2022
 License Number:

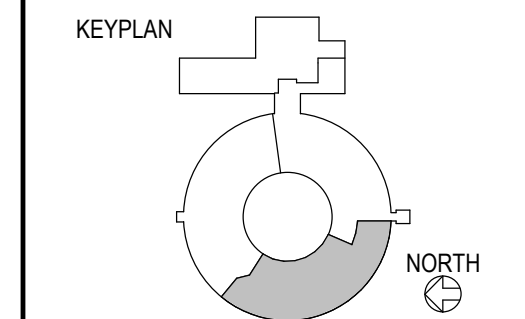

DRAWN BY: MB
 CHECKED BY: DMM
 ISSUED FOR CONSTRUCTION DOCUMENTS
 ISSUE DATE: OCTOBER 27, 2021
 SHEET NAME: REFLECTED CEILING PLAN

ATSR PROJECT NO.: 19039.2
 REVISION NO.: 2
 SHEET NUMBER